

GENERAL NOTES : -


1. ALL COLD WATER INSTALLATION INCLUDING ALL PIPES FITTINGS ETC. SHALL COMPLY TO THE REQUIREMENTS AND SPECIFICATIONS OF RELEVANT AUTHORITIES.
2. ALL COLD WATER SUPPLY RISER PIPE FROM WATER RETICULATION TO FLOOR ABOVE SHALL BE UPVC "CLASS 7" INTERNAL AND SUPPLY PIPE FROM RISER PIPE TO TOILET AND LAB FITTING SHALL BE PVC CLASS 7"
3. IN ADDITION TO STOP COCKS SHOWN IN DRAWINGS TO EVERY WATER CLOSET IT SHALL BE PROVIDED WITH STOP COCKS BEFORE THE CISTERN ASSEMBLY.
4. ALL PIPE SIZE INDICATED IN THE FLOOR PLAN AND SCHEMATIC ARE IN MM.
5. ALL EXPOSE VALVES STOP COCKS SHALL BE CHROME-PLATED.
6. THE INSTALLATION OF SANITARY FIXTURE AND FITTING SHALL BE IN ACCORDANCE ARCHITECTURAL DRAWING.
7. ALL SHOP DRAWINGS MUST BE APPROVED BEFORE ANY CONSTRUCTION/INSTALLATION BEGIN ANY DISCREPANCIES SHALL BE REFERRED TO THE ENGINEERS. ALL PIPE SHALL BE CHASED IN WALL AND SLAB WHERE POSSIBLE.

LEGENDS :

- | | | |
|---|---|----------------------------|
| sh. | — | SINK. |
| t. | — | TAP. |
| p.w.c. | — | PACIFIC WATER CLOSET. |
| a.w.c. | — | ASEAN WATER CLOSET. |
| b. | — | BASIN. |
| sh. | — | SHOWER |
| HDPE | — | HIGH DENSITY POLY ETHYLENE |
| PVC | — | POLY VINYL CHLORIDE |
|  | — | INCOMING PIPE RISER |
|  | — | PIPE SUPPLY TO FITTING |
|  | — | STOP COCK |



— **STOP COCK**

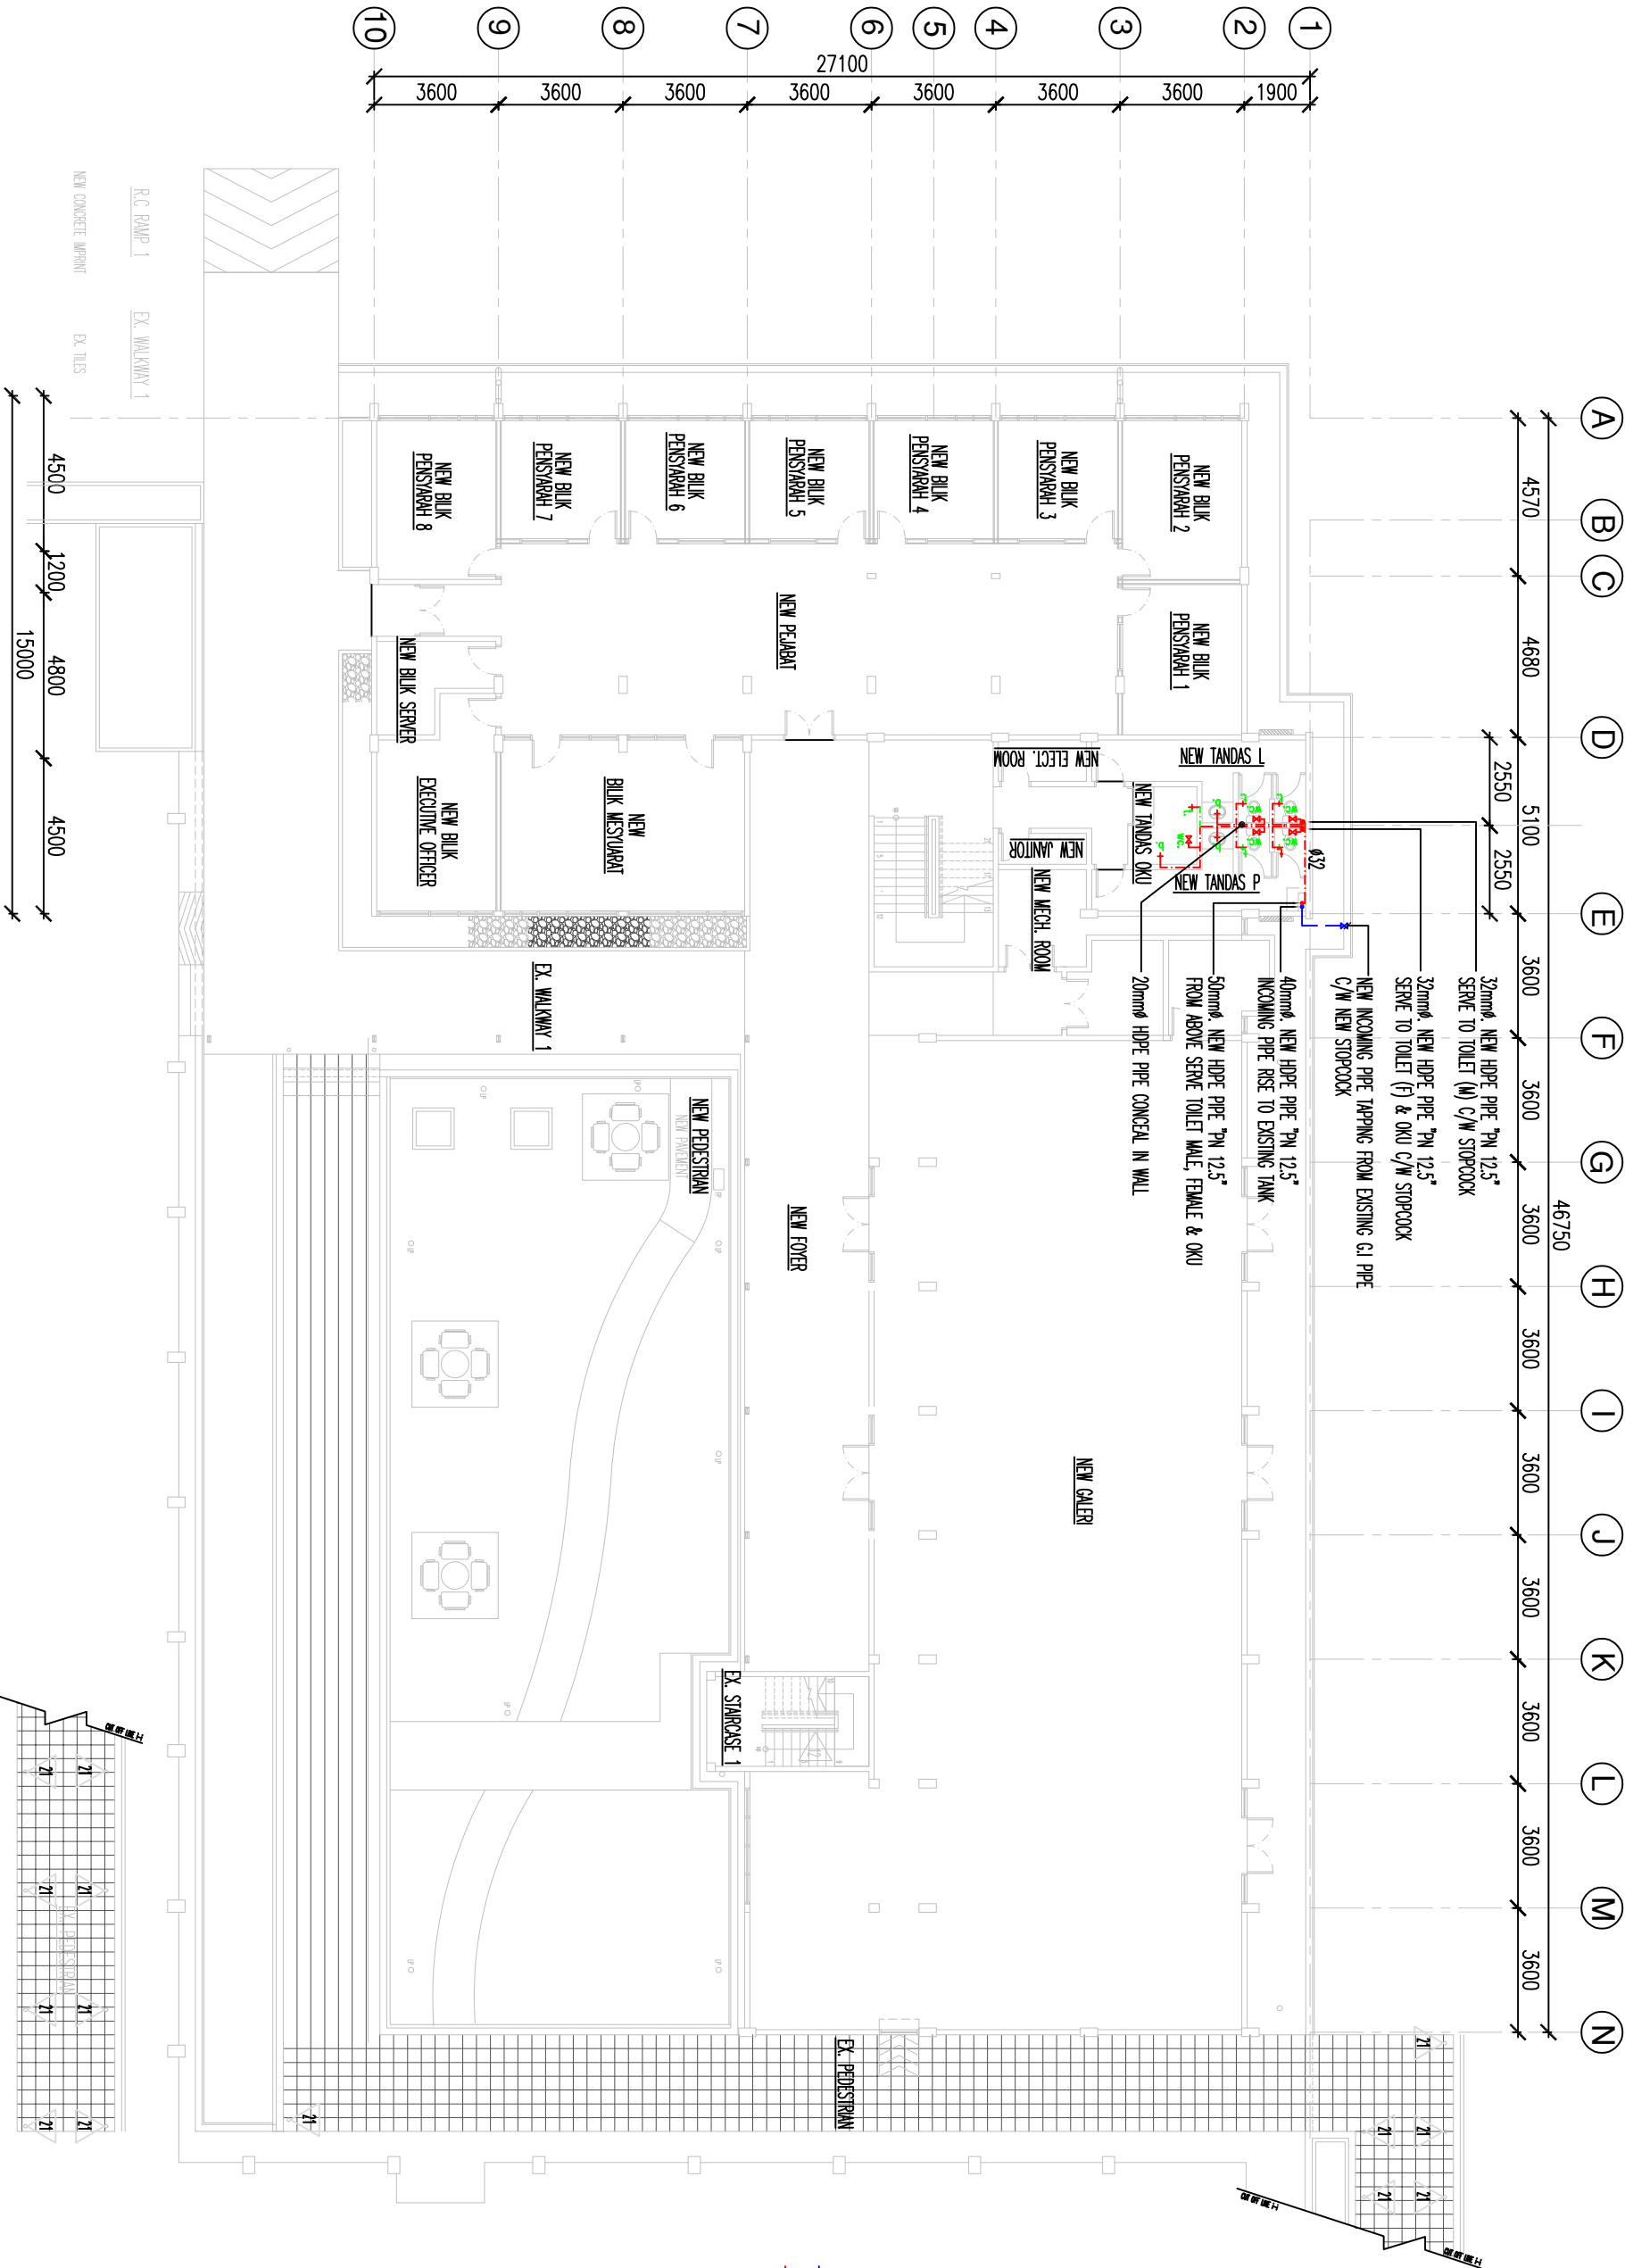

LUKISAN TENDER

PERINGATAN

HANYA DIMENSI BERANGKA SAHALA DIATAKAN, KONTRAKTOR MESTI MEMERKA SEMUA DIMENSI SEBENAR DI TAPAK BINA. SEBARANG PERCANGKAHAN MESTI DI LAPORAN DENGAN SECARA KEPADA PEGAWAI PENGUSAHA SEBELUM KERJAKERJA DIMULAKAN.

NO. RUJUKAN PROJEK:		TARIKH:		INDEKS PINDAAN	
200-PPI(BP1-5/3/138) [5001] MECH		20 25 JANUARI			
TAJUK LUKSAN:		SKALA:			
NEW LAYOUT PLAN - BLOK A ARAS 1		1:200			
PLUMBING SERVICES (COLD WATER SYSTEM)					
NAB CANSelor		: PROF. DATUK Dr. SHAHRIN SAHIB@SAHIBUDDIN			
TIMB. NAB CANSelor (PEMBANGUNAN)		: PROF. Ts. St. Dr. MD YUSOF HAMID			
PENGARAH BAHAGIAN PEMBANGUNAN INFRASTRUKTUR		: Ir. Ts. AZMAN SAUBIRAN			
KETUA BAHAGIAN PEMBANGUNAN INFRA		: TS. MOHAMMED IZRA ABD BALAZ			
ARKITEK		: ZULFADU MOHAMMED SALEH			
DILUKIS OLEH		: Ir. AHMAD ABIDI BIN JAAFER		NO	
PENGURUS PROJEK / DISEMAK		: AZAIDI AZIZI		HELANAN: 07	

PELAN KERJA BARU - BLOK A LANTAI ARAS 1
ULTIM JALAN OTHMAN

PROJEK:
KERJA MEMBAIKPULIH, MENAIKTAARAF SERTA KERJA -KERJA
YANG BERTKAITAN DI BANGUNAN BLOK A UNTUK UNIVERSITI
TEKNOLOGI MARA DI UTM KAMPUS JALAN OTHMAN,
PETALING JAYA, SELANGOR DARUL EHSAN




UNIVERSITI
TEKNOLOGI
MARARA

GENERAL NOTES : -

1. ALL COLD WATER INSTALLATION INCLUDING ALL PIPES FITTINGS ETC. SHALL COMPLY TO THE REQUIREMENTS AND SPECIFICATIONS OF RELEVANT AUTHORITIES.
2. ALL COLD WATER SUPPLY RISER PIPE FROM WATER RETICULATION TO FLOOR ABOVE SHALL BE UPVC "CLASS 7" INTERNAL AND SUPPLY PIPE FROM RISER PIPE TO TOILET AND LAB FITTING SHALL BE PVC CLASS 7"
3. IN ADDITION TO STOP COCKS SHOWN IN DRAWINGS TO EVERY WATER CLOSET IT SHALL BE PROVIDED WITH STOP COCKS BEFORE THE CISTERN ASSEMBLY.
4. ALL PIPE SIZE INDICATED IN THE FLOOR PLAN AND SCHEMATIC ARE IN MM.
5. ALL EXPOSE VALVES STOP COCKS SHALL BE CHROME-PLATED.
6. THE INSTALLATION OF SANITARY FIXTURE AND FITTING SHALL BE IN ACCORDANCE ARCHITECTURAL DRAWING.
7. ALL SHOP DRAWINGS MUST BE APPROVED BEFORE ANY CONSTRUCTION/INSTALLATION BEGIN ANY DISCREPANCIES SHALL BE REFERRED TO THE ENGINEERS. ALL PIPE SHALL BE CHASED IN WALL AND SLAB WHERE POSSIBLE.

LEGENDS :

- | | | |
|---|---|----------------------------|
|  | — | SINK. |
|  | — | TAP. |
|  | — | PACIFIC WATER CLOSET. |
|  | — | ASEAN WATER CLOSET. |
|  | — | BASIN. |
|  | — | SHOWER |
|  | — | HIGH DENSITY POLY ETHYLENE |
|  | — | POLY VINYL CHLORIDE |
|  | — | INCOMING PIPE RISER |
|  | — | PIPE SUPPLY TO FITTING |
|  | — | STOP COCK |

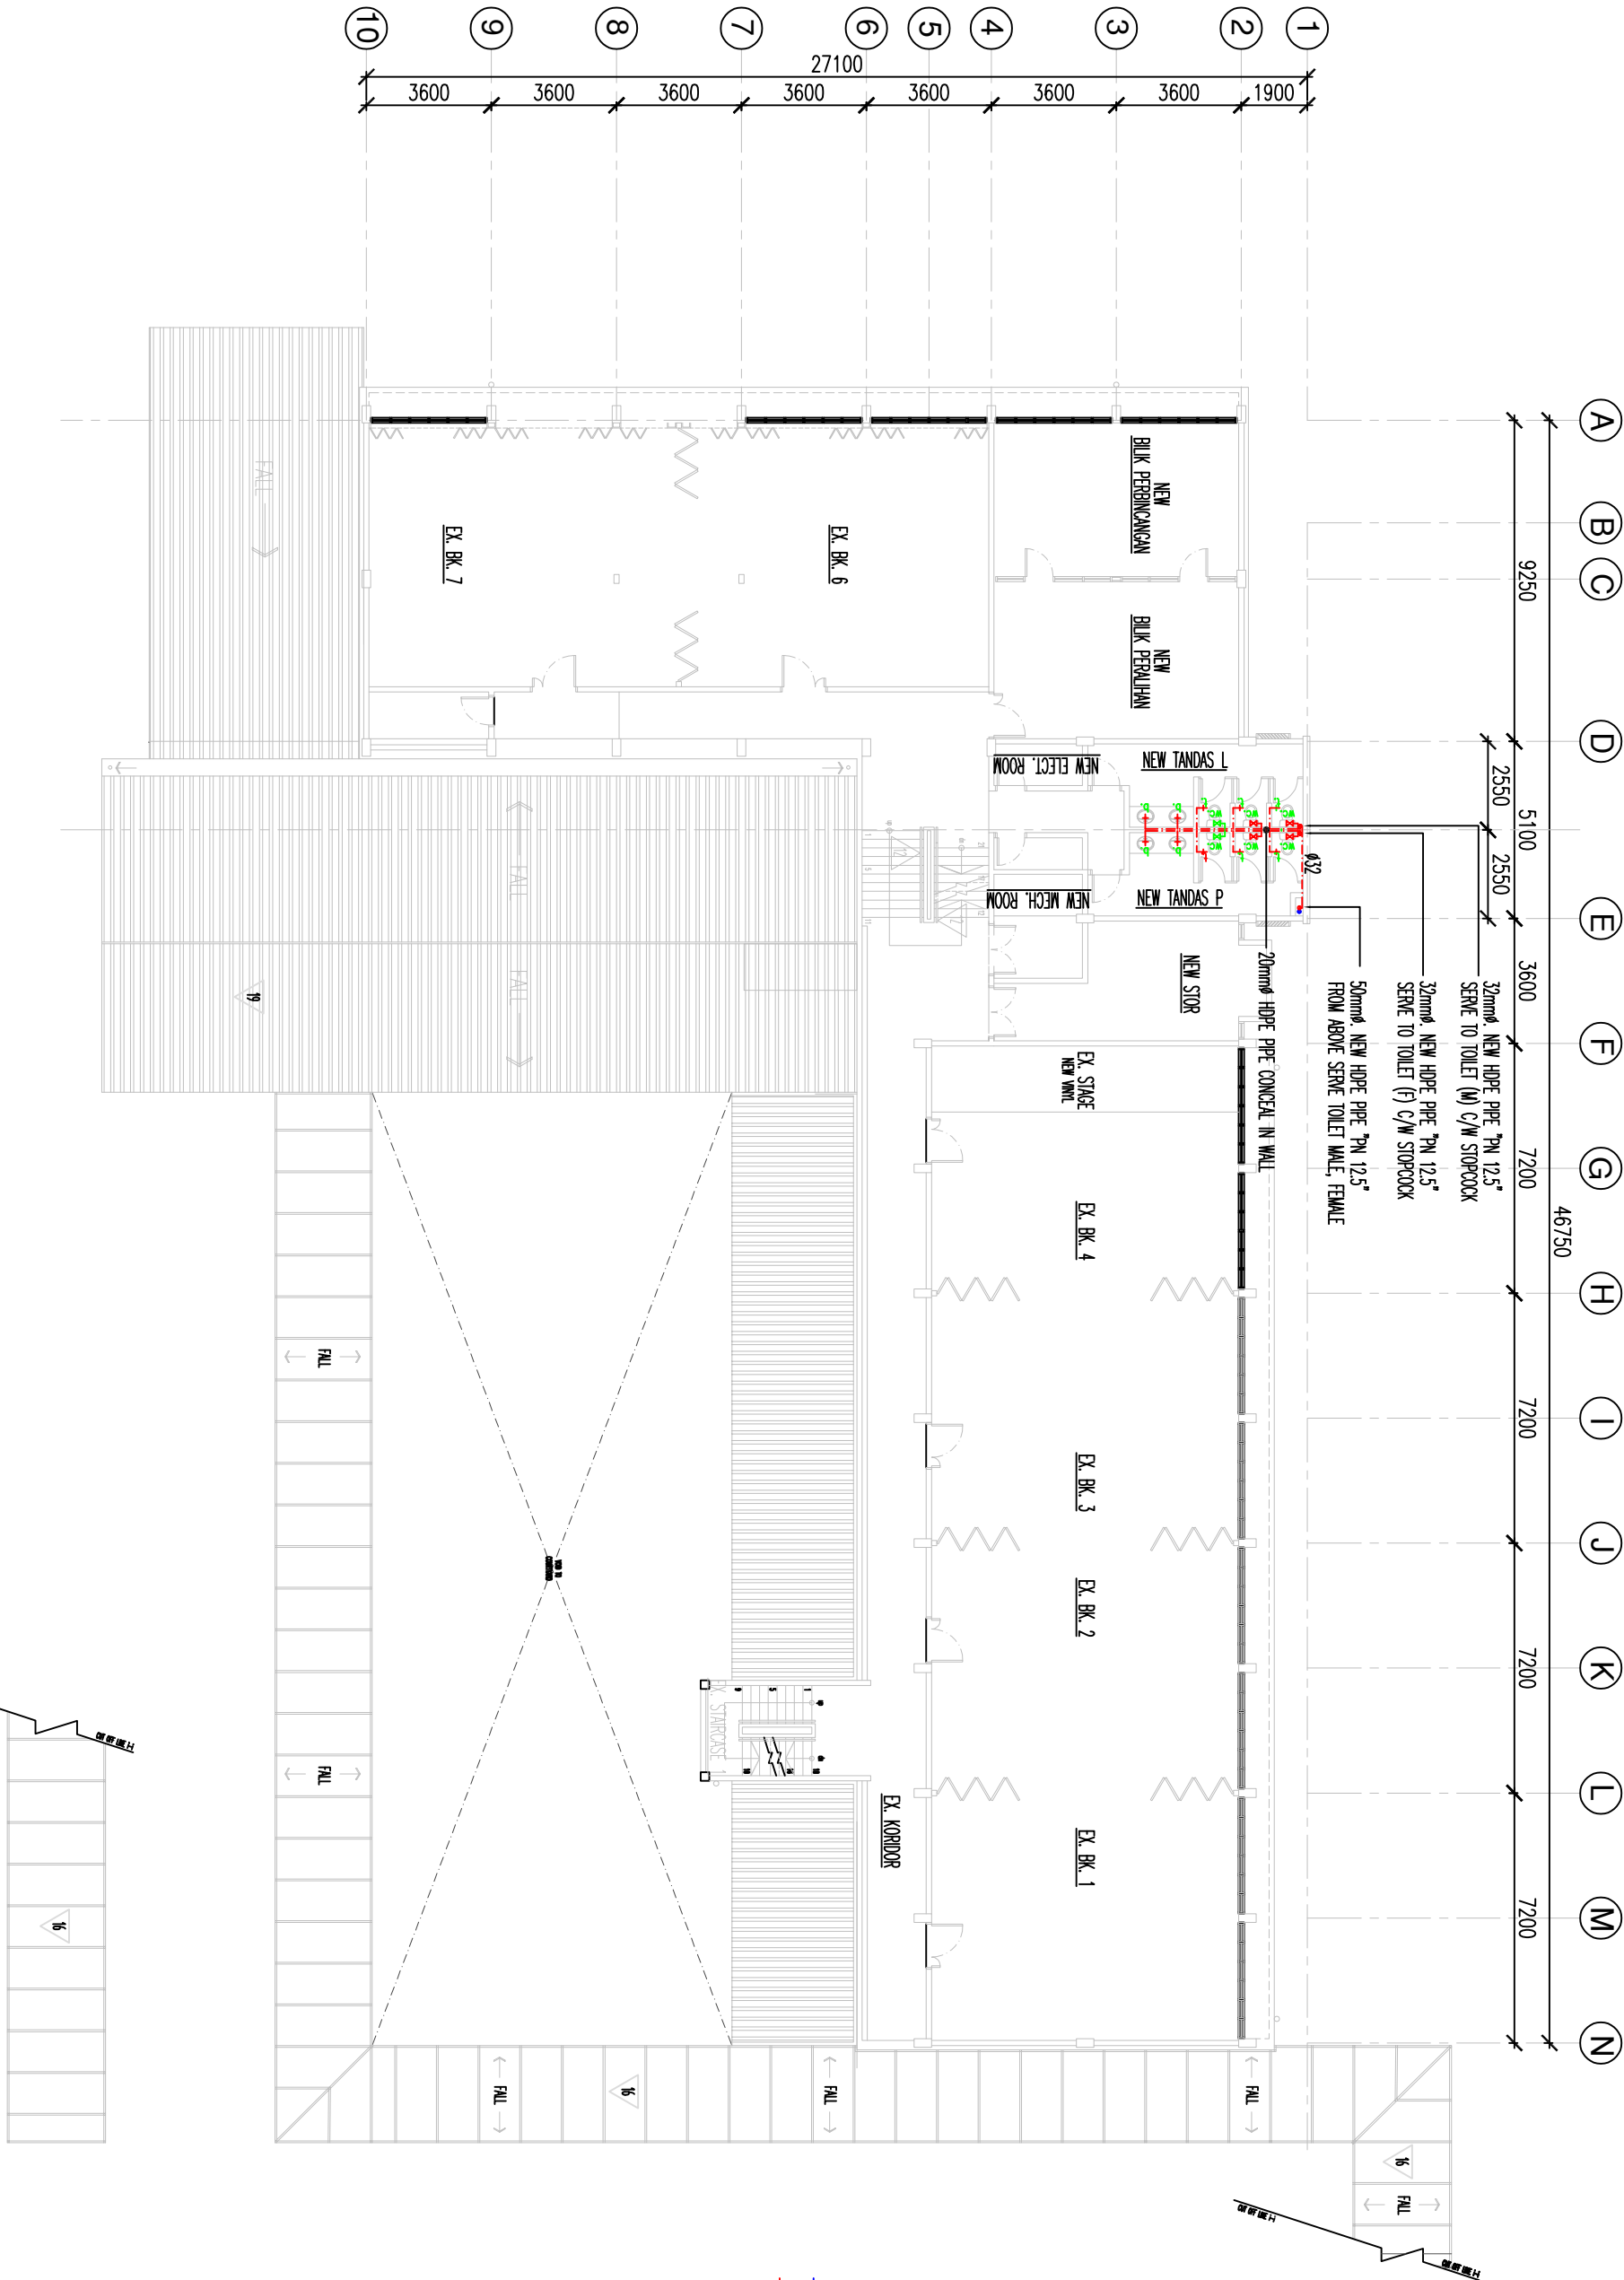

LUKISAN TENDER

PELAN KERJA BARU - BLOK A LANTAI ARAS 2

UITM JALAN OTHMAN

PROJEK:
KERJA MEMBAIKPULIH, MENAIKTARAF SERTA KERJA -KERJA YANG BERKAITAN DI BANGUNAN BLOK A UNTUK UNIVERSITI TEKNOLOGI MARA DI UTM KAMPUS JALAN OTHMAN, PETALING JAYA, SELANGOR DARUL EHSAN



UNIVERSITI
TEKNOLOGI
MARARA

NO. RUJUKAN PROJEK: 200-PPII(BP1-5/3/138) [50002] MECH		TARIKH: 20 25 JANUARI	NAIB CANSOLOR : PROF. DATUK DR. SHAHRIN SAHIB@SAHIBUDDIN		INDUKS PINDAAN	
			TIMB. NAIB CANSOLOR (PEMBANGUNAN) : PROF. TS. ST. DR. MD YUSOF HAMID			
			PENGARAH BAHAGIAN PEMBANGUNAN : INFRASTRUKTUR : Ir. TS. AZMAN SAUBIRAN			
			KETUA BAHAGIAN PEMBANGUNAN INFRA: TS. MOHAMMED IZZA ABD RAZAK			
TAJUK LUKSIAN: NEW LAYOUT PLAN - BLOK A ARAS 2 PLUMBING SERVICES (COLD WATER SYSTEM)		SKALA:	ARKTEK : ZULFADLI MOHAMED SALLEH			
			DILUKIS OLEH : Ir. AHMAD ABIDI BIN JAFAAR			
			PENGURUS PROJEK / DISEMAK : AZAIDI AZIZ		NO HELMAN:	08

PERINGATAN


HANYA DIMENSI BERANGKA SAMAJA DILAKSANAKAN, KONTRAKTOR MESTI MEMERIKSA SEMUA DIMENSI SEBENAR DI TAPAK BINA. SEBARANG PERCANGGAHAN MESTI DILAPORKAN DENGAN SENERGA KEPADA PEGAWAI PENGUSAHA SEBELUM KERJAKERJA DIMULAKAN.

GENERAL NOTES : -

1. ALL COLD WATER INSTALLATION INCLUDING ALL PIPES FITTINGS ETC. SHALL COMPLY TO THE REQUIREMENTS AND SPECIFICATIONS OF RELEVANT AUTHORITIES.
2. ALL COLD WATER SUPPLY RISER PIPE FROM WATER RETICULATION TO FLOOR ABOVE SHALL BE UPVC CLASS 7" INTERNAL AND SUPPLY PIPE FROM RISER PIPE TO TOILET AND LAB FITTING SHALL BE PVC CLASS 7"
3. IN ADDITION TO STOP COCKS SHOWN IN DRAWINGS TO EVERY WATER CLOSET IT SHALL BE PROVIDED WITH STOP COCKS BEFORE THE CISTERN ASSEMBLY.
4. ALL PIPE SIZE INDICATED IN THE FLOOR PLAN AND SCHEMATIC ARE IN MM.
5. ALL EXPOSE VALVES STOP COCKS SHALL BE CHROME-PLATED.
6. THE INSTALLATION OF SANITARY FIXTURE AND FITTING SHALL BE IN ACCORDANCE ARCHITECTURAL DRAWING.
7. ALL SHOP DRAWINGS MUST BE APPROVED BEFORE ANY CONSTRUCTION/INSTALLATION BEGIN ANY DISCREPANCIES SHALL BE REFERRED TO THE ENGINEERS. ALL PIPE SHALL BE CHASED IN WALL AND SLAB WHERE POSSIBLE.

LEGENDS :

- | | |
|---|----------------------------|
|  | SINK. |
|  | TAP. |
|  | PACIFIC WATER CLOSET. |
|  | ASEAN WATER CLOSET. |
|  | BASIN. |
|  | SHOWER. |
|  | HIGH DENSITY POLY ETHYLENE |
|  | POLY VINYL CHLORIDE |
|  | INCOMING PIPE RISER |
|  | PIPE SUPPLY TO FITTING |
|  | STOP COCK |

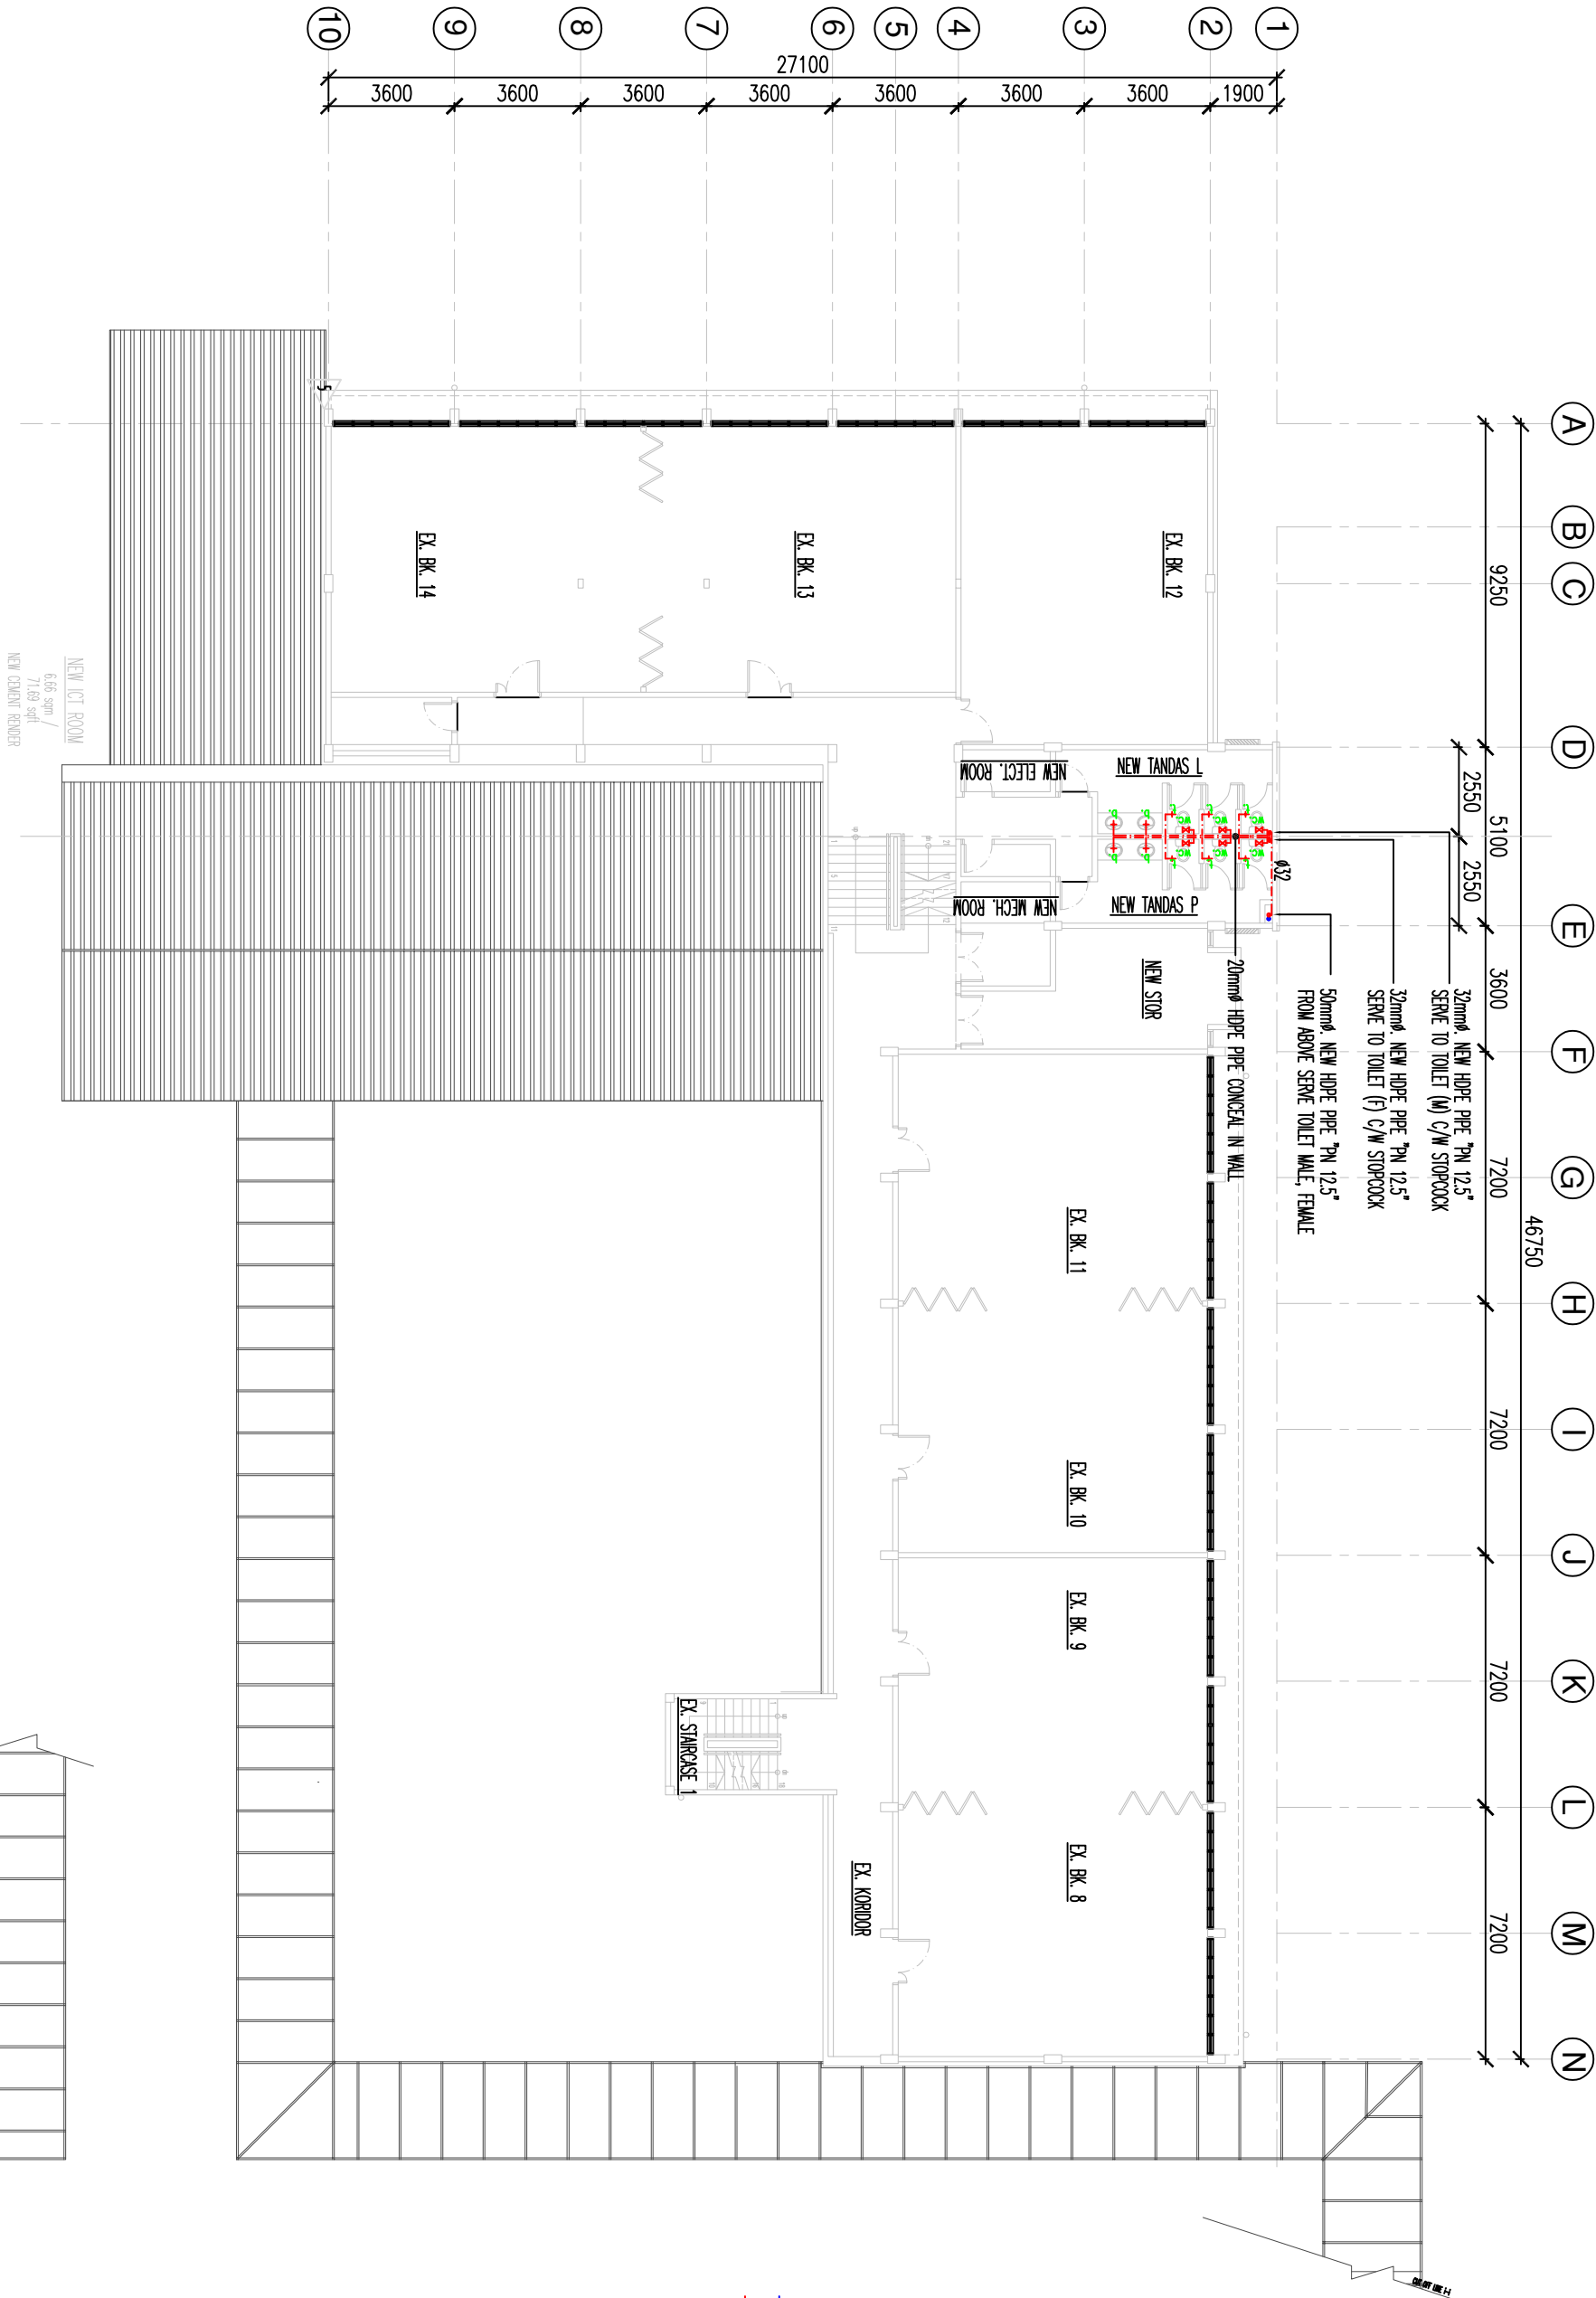

LUKISAN TENDER

PELAN KERJA BARU - BLOK A LANTAI ARAS 3

UITM JALAN OTHMAN

PROJEK:
KERJA MEMBAIKPULIH, MENAKTARAF SERTA KERJA -KERJA
YANG BERKAITAN DI BANGUNAN BLOK A UNTUK UNIVERSITI
TEKNOLOGI MARA DI UTM KAMPUS JALAN OTHMAN,
PETALING JAYA, SELANGOR DARUL EHSAN



UNIVERSITI
TEKNOLOGI
MARARA

NO. RUJUKAN PROJEK: 200-PPII(BP-1-5/3/138) [50003] MECH		TARIKH: 20 JANUARI		INDENES PINDAAN	
TAJUK LUKISAN: NEW LAYOUT PLAN - BLOK A ARAS 3 PLUMBING SERVICES (COLD WATER SYSTEM)		SKALA: 1:200		NO HELAAN: 09	
NAIB CANSOLOR : PROF. DATUK D. SHAHRIN SAHIB@SAHIBUDIN		TIMB. NAIB CANSOLOR (PEMBANGUNAN) : PROF. TS. ST. DR. MD YUSOF HAMID			
PENGESEK BAHAGIAN PEMBANGUNAN : IR. TS. AZMAN SAUBIRAN		PENGESEK BAHAGIAN PEMERIKHAAN : IR. TS. MOHAMMED IZZAL ABD RAZAK			
ARKTEK : ZULFADU MOHAMED SALLEH		DILUKIS OLEH : IR. AHMAD ABDUL BIN JAAFAR			
PENGURUS PROJEK / DISEMAK : AZADI AZIZI					

PERINGATAN

HANYA DIMENSI BEBANGA SAHAJA DILAKSANAKAN. KONTRAKTOR MESTI MEMERIKSA SEMUA DIMENSI SEBENAR DI TAPAK BINA. SEBAIANG PERCANGKAHAN MESTI DILAPORKAN DENGAN SECERA KEPADA PEGAWAI PENGUASA SEBELUM KERJAKERJA DIMULAKAN.

GENERAL NOTES : -

1. ALL COLD WATER INSTALLATION INCLUDING ALL PIPES FITTINGS ETC. SHALL COMPLY TO THE REQUIREMENTS AND SPECIFICATIONS OF RELEVANT AUTHORITIES.
2. ALL COLD WATER SUPPLY RISER PIPE FROM WATER RETICULATION TO FLOOR ABOVE SHALL BE UPVC "CLASS 7" INTERNAL AND SUPPLY PIPE FROM RISER PIPE TO TOILET AND LAB FITTING SHALL BE PVC "CLASS 7"
3. IN ADDITION TO STOP COCKS SHOWN IN DRAWINGS TO EVERY WATER CLOSET IT SHALL BE PROVIDED WITH STOP COCKS BEFORE THE CISTERN ASSEMBLY.
4. ALL PIPE SIZE INDICATED IN THE FLOOR PLAN AND SCHEMATIC ARE IN MM.
5. ALL EXPOSE VALVES STOP COCKS SHALL BE CHROME-PLATED.
6. THE INSTALLATION OF SANITARY FIXTURE AND FITTING SHALL BE IN ACCORDANCE ARCHITECTURAL DRAWING.
7. ALL SHOP DRAWINGS MUST BE APPROVED BEFORE ANY CONSTRUCTION/INSTALLATION BEGIN ANY DISCREPANCIES SHALL BE REFERRED TO THE ENGINEERS. ALL PIPE SHALL BE CHASED IN WALL AND SLAB WHERE POSSIBLE.

LEGENDS :

- sk.

-

SINK.
- t.

-

TAP.
- p.w.c

-

PACIFIC WATER CLOSET.
- a.w.c

-

ASEAN WATER CLOSET.
- b.

-

BASIN.
- sh.

-


SHOWER.
- HDPE

-

HIGH DENSITY POLY ETHYLENE
- PVC

-

POLY VINYL CHLORIDE
- INCOMING PIPE RISER
- PIPE SUPPLY TO FITTING
- STOP COCK

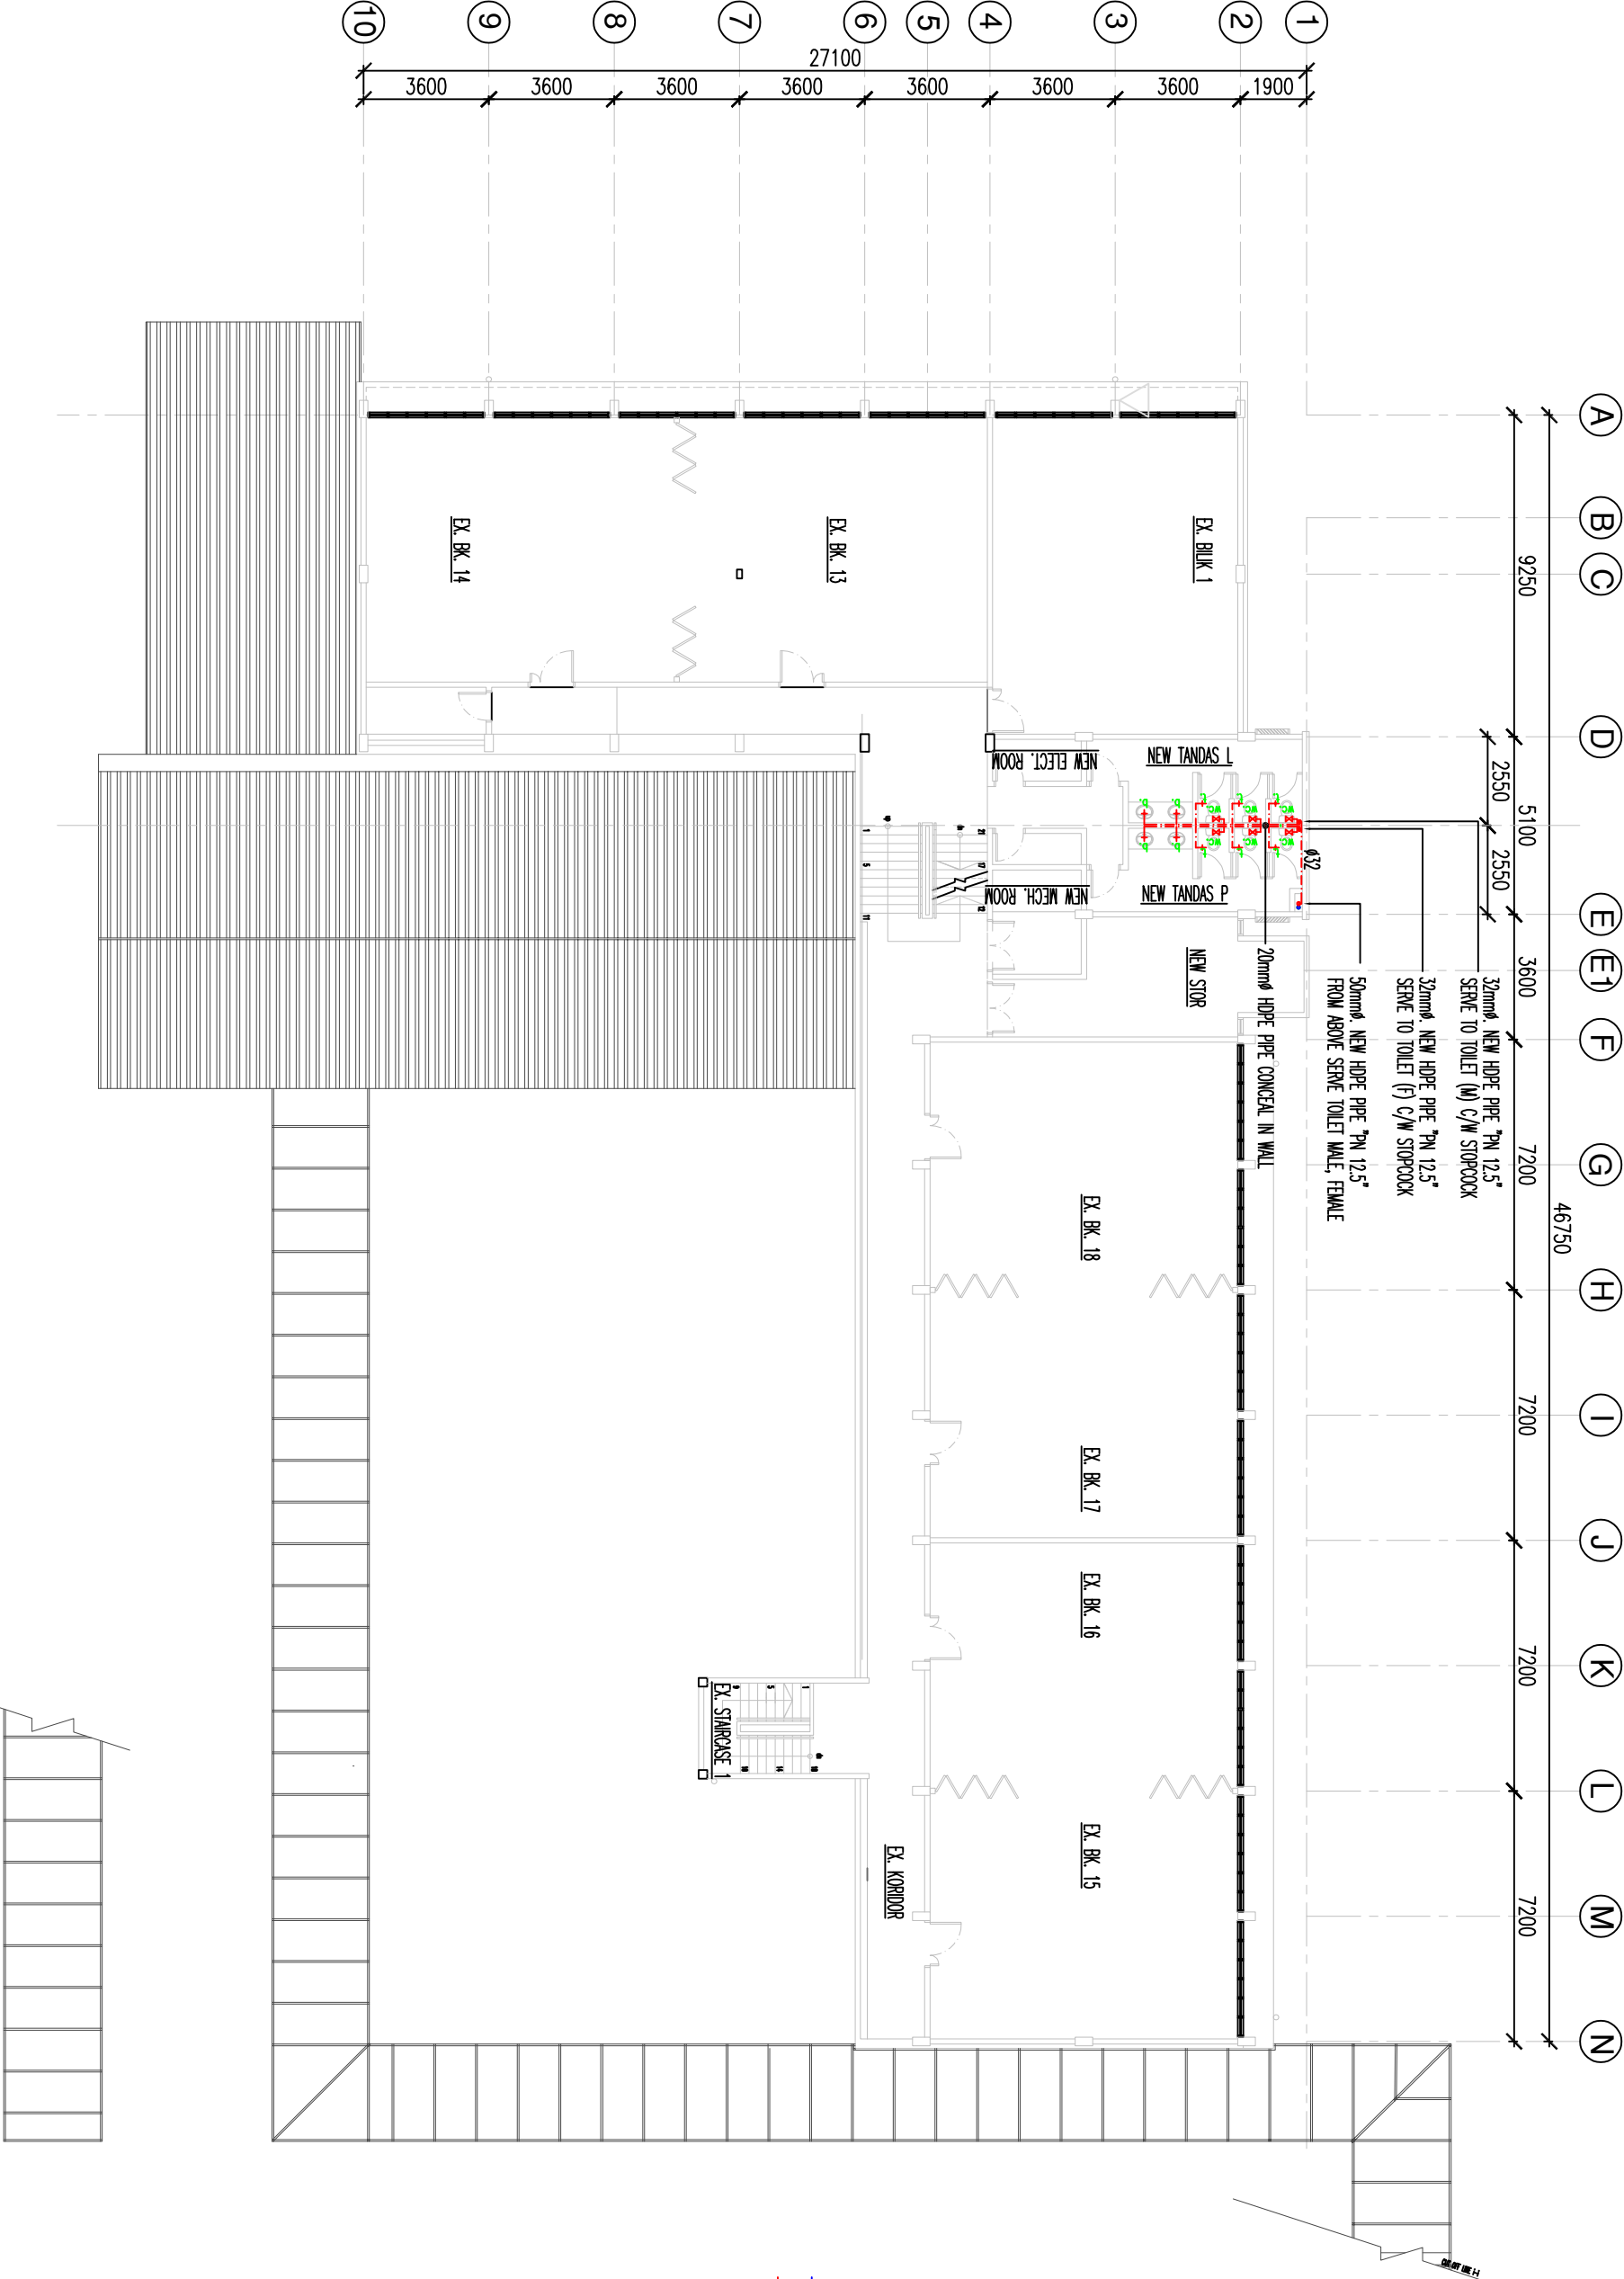

LUKISAN TENDER

PELAN KERJA BARU - BLOK A LANTAI ARAS 4	
UTIM JALAN OTHMAN	
PERINGATAN	
HANYA DIMENSI BERANGKA SAHAJA DILAKSANAKAN. KONTRAKTOR MESTI MEMERIKSA SEMUA DIMENSI SEBENAR DI TAPAK BINA. SEBARANG PERCANGKAHAN MESTI DILAPORKAN DENGAN SECERA KEPADA PEGAWAI PENGUASA SEBELUM KERJA-KERJA DIMULAKAN.	

PROJEK:
KERJA MEMBAIKPULIH, MENAIKTARAF SERTA KERJA -KERJA YANG BERKAITAN DI BANGUNAN BLOK A UNTUK UNIVERSITI TEKNOLOGI MARA DI UTIM KAMPUS JALAN OTHMAN, PETALING JAYA, SELANGOR DARUL EHSAN



NO. RUJUKAN PROJEK:		TARIKH:		NABIB CANSELOR	
200-PII(BPI-5/3/138) [5004] MECH		20 JANUARI		TIMB. NABIB CANSELOR (PEMBANGUNAN) : PROF. TS. ST. DR. MD YUSOF HAMID	
TAJUK LUKISAN:		SKALA:		PENGARAH BAHAGIAN PEMBANGUNAN : IR. TS. AZMAN SAUBIRAN	
NEW LAYOUT PLAN - BLOK A ARAS 4		1:200		KETUA BAHAGIAN PEMBANGUNAN INTRA: TS. MOHAMMED URAI ABD RAZAK	
PLUMBING SERVICES (COLD WATER SYSTEM)				ARKITEK : ZULFADLI MOHAMED SALLEH	
				DILUKIS OLEH : IR. AHMAD ABDUL BIN JAAFAR	
				PENGURUS PROJEK / DISMAK : AZADI AZIZ	
				NO HELIAN:	
				10	

GENERAL NOTES :-

- ALL COLD WATER INSTALLATION INCLUDING ALL PIPES FITTINGS ETC. SHALL COMPLY TO THE REQUIREMENTS AND SPECIFICATIONS OF RELEVANT AUTHORITIES.
- ALL COLD WATER SUPPLY RISER PIPE FROM WATER RETICULATION TO FLOOR ABOVE SHALL BE UPVC "CLASS 7" INTERNAL AND SUPPLY PIPE FROM RISER PIPE TO TOILET AND LAB FITTING SHALL BE PVC "CLASS 7"
- IN ADDITION TO STOP COCKS SHOWN IN DRAWINGS TO EVERY WATER CLOSET IT SHALL BE PROVIDED WITH STOP COCKS BEFORE THE CISTERN ASSEMBLY.
- ALL PIPE SIZE INDICATED IN THE FLOOR PLAN AND SCHEMATIC ARE IN MM.
- ALL EXPOSE VALVES STOP COCKS SHALL BE CHROME-PLATED.
- THE INSTALLATION OF SANITARY FIXTURE AND FITTING SHALL BE IN ACCORDANCE ARCHITECTURAL DRAWING.
- ALL SHOP DRAWINGS MUST BE APPROVED BEFORE ANY CONSTRUCTION/INSTALLATION BEGIN ANY DISCREPANCIES SHALL BE REFERRED TO THE ENGINEERS. ALL PIPE SHALL BE CHASED IN WALL AND SLAB WHERE POSSIBLE.

LEGENDS :

- sk.

-

SINK.
- t.

-

TAP.
- p.w.c

-

PACIFIC WATER CLOSET.
- a.w.c

-

ASEAN WATER CLOSET.
- b.

-

BASIN.
- sh.

-


SHOWER.
- HDPE

-

HIGH DENSITY POLY ETHYLENE
- PVC

-

POLY VINYL CHLORIDE
- INCOMING PIPE RISER
- PIPE SUPPLY TO FITTING
- STOP COCK

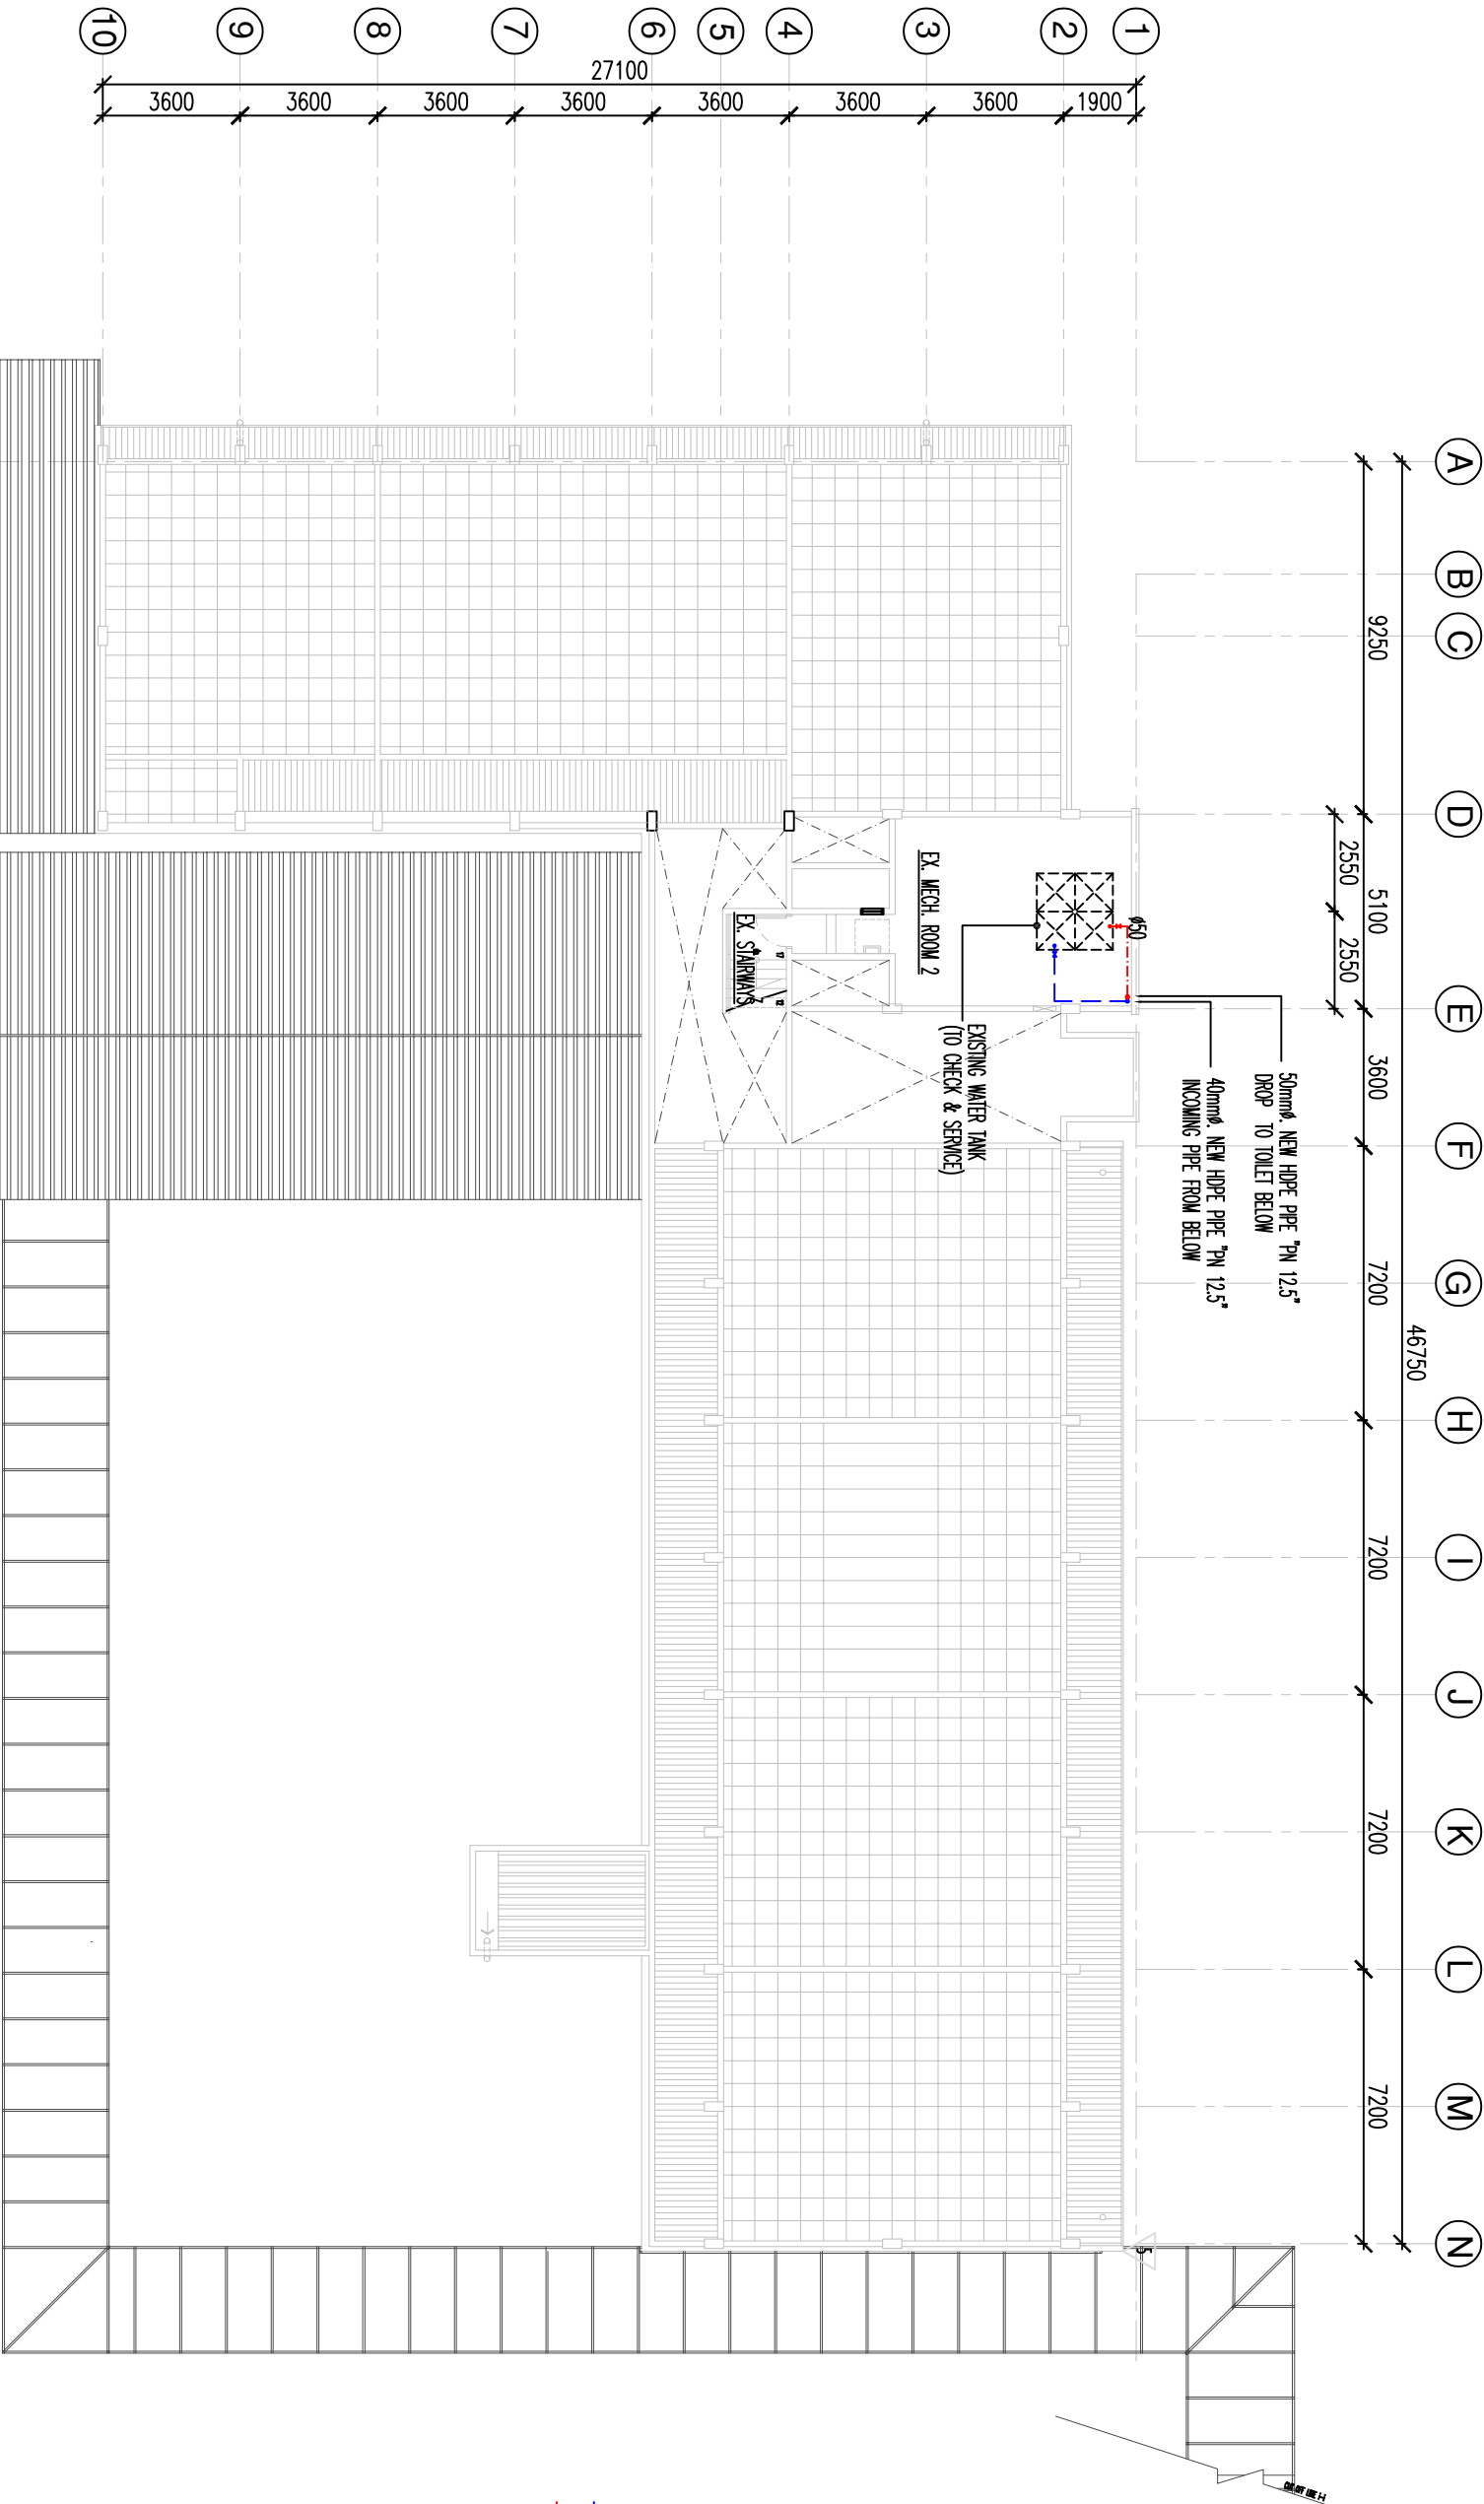

LUKISAN TENDER

PELAN KERJA BARU - BLOK A ARAS BUMBUNG

UTIM JALAN OTHMAN

PROJEK:
KERJA MEMBAIKPULIH, MENAIKTARAF SERTA KERJA -KERJA YANG BERKAITAN DI BANGUNAN BLOK A UNTUK UNIVERSITI TEKNOLOGI MARA DI UTIM KAMPUS JALAN OTHMAN, PETALING JAYA, SELANGOR DARUL EHSAN



NO. RUJUKAN PROJEK: 200-PII(BPI-5/3/138) [5005] MECH		TARIKH: 20 25 JANUARI	NABIB CANSOLOR : PROF. DATUK DR. SHAHRIN SAHIB@SAHIBUDDIN		INDEXS PINDAAN
			TIMB. NABIB CANSOLOR (PEMBANGUNAN) : PROF. TS. ST. DR. MD YUSOF HAMID		
TAJUK LUKISAN: NEW LAYOUT PLAN - BLOK A ARAS 1 PLUMBING SERVICES (COLD WATER SYSTEM))		SKALA: 1:200	PENGARAH BAHAGIAN PEMBANGUNAN : IR. TS. AZMAN SAUBIRAN REKABERSIKUTUR KETUA BAHAGIAN PEMBANGUNAN INTRA: TS. MOHAMMED IZZA ABD RAZAK		
			ARKITEK : ZULFADLI MOHAMED SALLEH		
			DILUKIS OLEH : IR. AHMAD ABIDI BIN JAAFAR		
			PENGURUS PROJEK / DISEMAK : AZAIDI AZIZ		NO HELAAN: 11

PERINGATAN
HANYA DIMENSI BERANGKA SAHAJA DILAKSANAKAN.
KONTRAKTOR MUSTI MEMERIKSA SEMUA DIMENSI SEBENAR DI TAPAK BINA. SEBARANG PERCANGKAHAN MUSTI DILAPORKAN DENGAN SEGERA KEPADA PEGAWAI PENGUASA SEBELUM KERJA-KERJA DIMULAKAN.